


GENERAL NOTES

REMOVE EXISTING EXHAUST AIR DEVICES. CLEAN AND REINSTALL AFTER DUCT CLEANING IS COMPLETE. ALL EXISTING EXHAUST DUCTWORK SHALL BE INTERNALLY CLEANED BY THE HVAC CONTRACTOR. RE-BALANCE GRILLES TO CFM NOTED ON DRAWINGS.
REMOVE EXISTING CEILING GRID AND REINSTALL TO ALLOW INSTALLATION OF NEW PIPING. STORE CEILING TILES AND PROTECT. REINSTALL CEILING GRID AFTER PIPING HAS BEEN INSTALLED.

CODED NOTES


- EXISTING RELIEF AIR FAN TO REMAIN.
- EXISTING DOAS UNIT TO REMAIN.
- EXISTING AIR DEVICE TO REMAIN. BALANCE TO AIRFLOW NOTED.
- EXISTING DUCTWORK UP TO EXHAUST FAN IN ATTIC TO REMAIN.
- BALANCE EXISTING AIR DEVICE TO CFM NOTED ON DRAWINGS.
- 12"x10" UP TO SECOND FLOOR DORM ROOM. PROVIDE FIRE DAMPER AND ACCESS DOOR AT FLOOR PENETRATION.
- RECONNECT EXISTING CHWS/CHWR & HWHS/HWHR.
- NEW 2" HWHS&R AND CHWS&R PIPING UP THRU FLOOR TO NEW DOAS UNITS AND FAN COIL UNITS IN ATTIC. PROVIDE ISOLATION BALL VALVES AS SHOWN.
- EXISTING DUCTWORK TO REMAIN.
- FIELD COORDINATE EXACT ROUTE FOR NEW PIPING. RUN ONE OF THE NEW 3" PIPES ABOVE THE OTHER THREE. PROVIDE NECESSARY OFFSETS FOR THE NEW ROUTE. PIPES ALL SHOWN SIDE BY SIDE FOR DRAWING CLARITY.
- TEMPORARILY REMOVE EXISTING DUCTWORK AS REQUIRED FOR INSTALLATION OF NEW PIPING. REINSTALL DUCTWORK AFTER PIPING IS INSTALLED.
- REMOVE EXISTING CEILING GRID AND REINSTALL TO ALLOW INSTALLATION OF NEW PIPING. STORE CEILING TILES AND PROTECT. REINSTALL CEILING GRID AFTER PIPING HAS BEEN INSTALLED.
- TEMPORARILY REMOVE PORTION OF EXISTING DUCTWORK AS REQUIRED FOR INSTALLATION OF NEW PIPING. NEW PIPING TO RUN TIGHT TO THE SOUTH SIDE OF THE CORRIDOR. SHOWN ON PLANS IN MIDDLE FOR DRAWING CLARITY.
- THE EXISTING CORRIDORS ARE TIGHT. CAREFUL COORDINATE IS REQUIRED. PROVIDE NECESSARY OFFSETS TO INSTALL NEW PIPING.

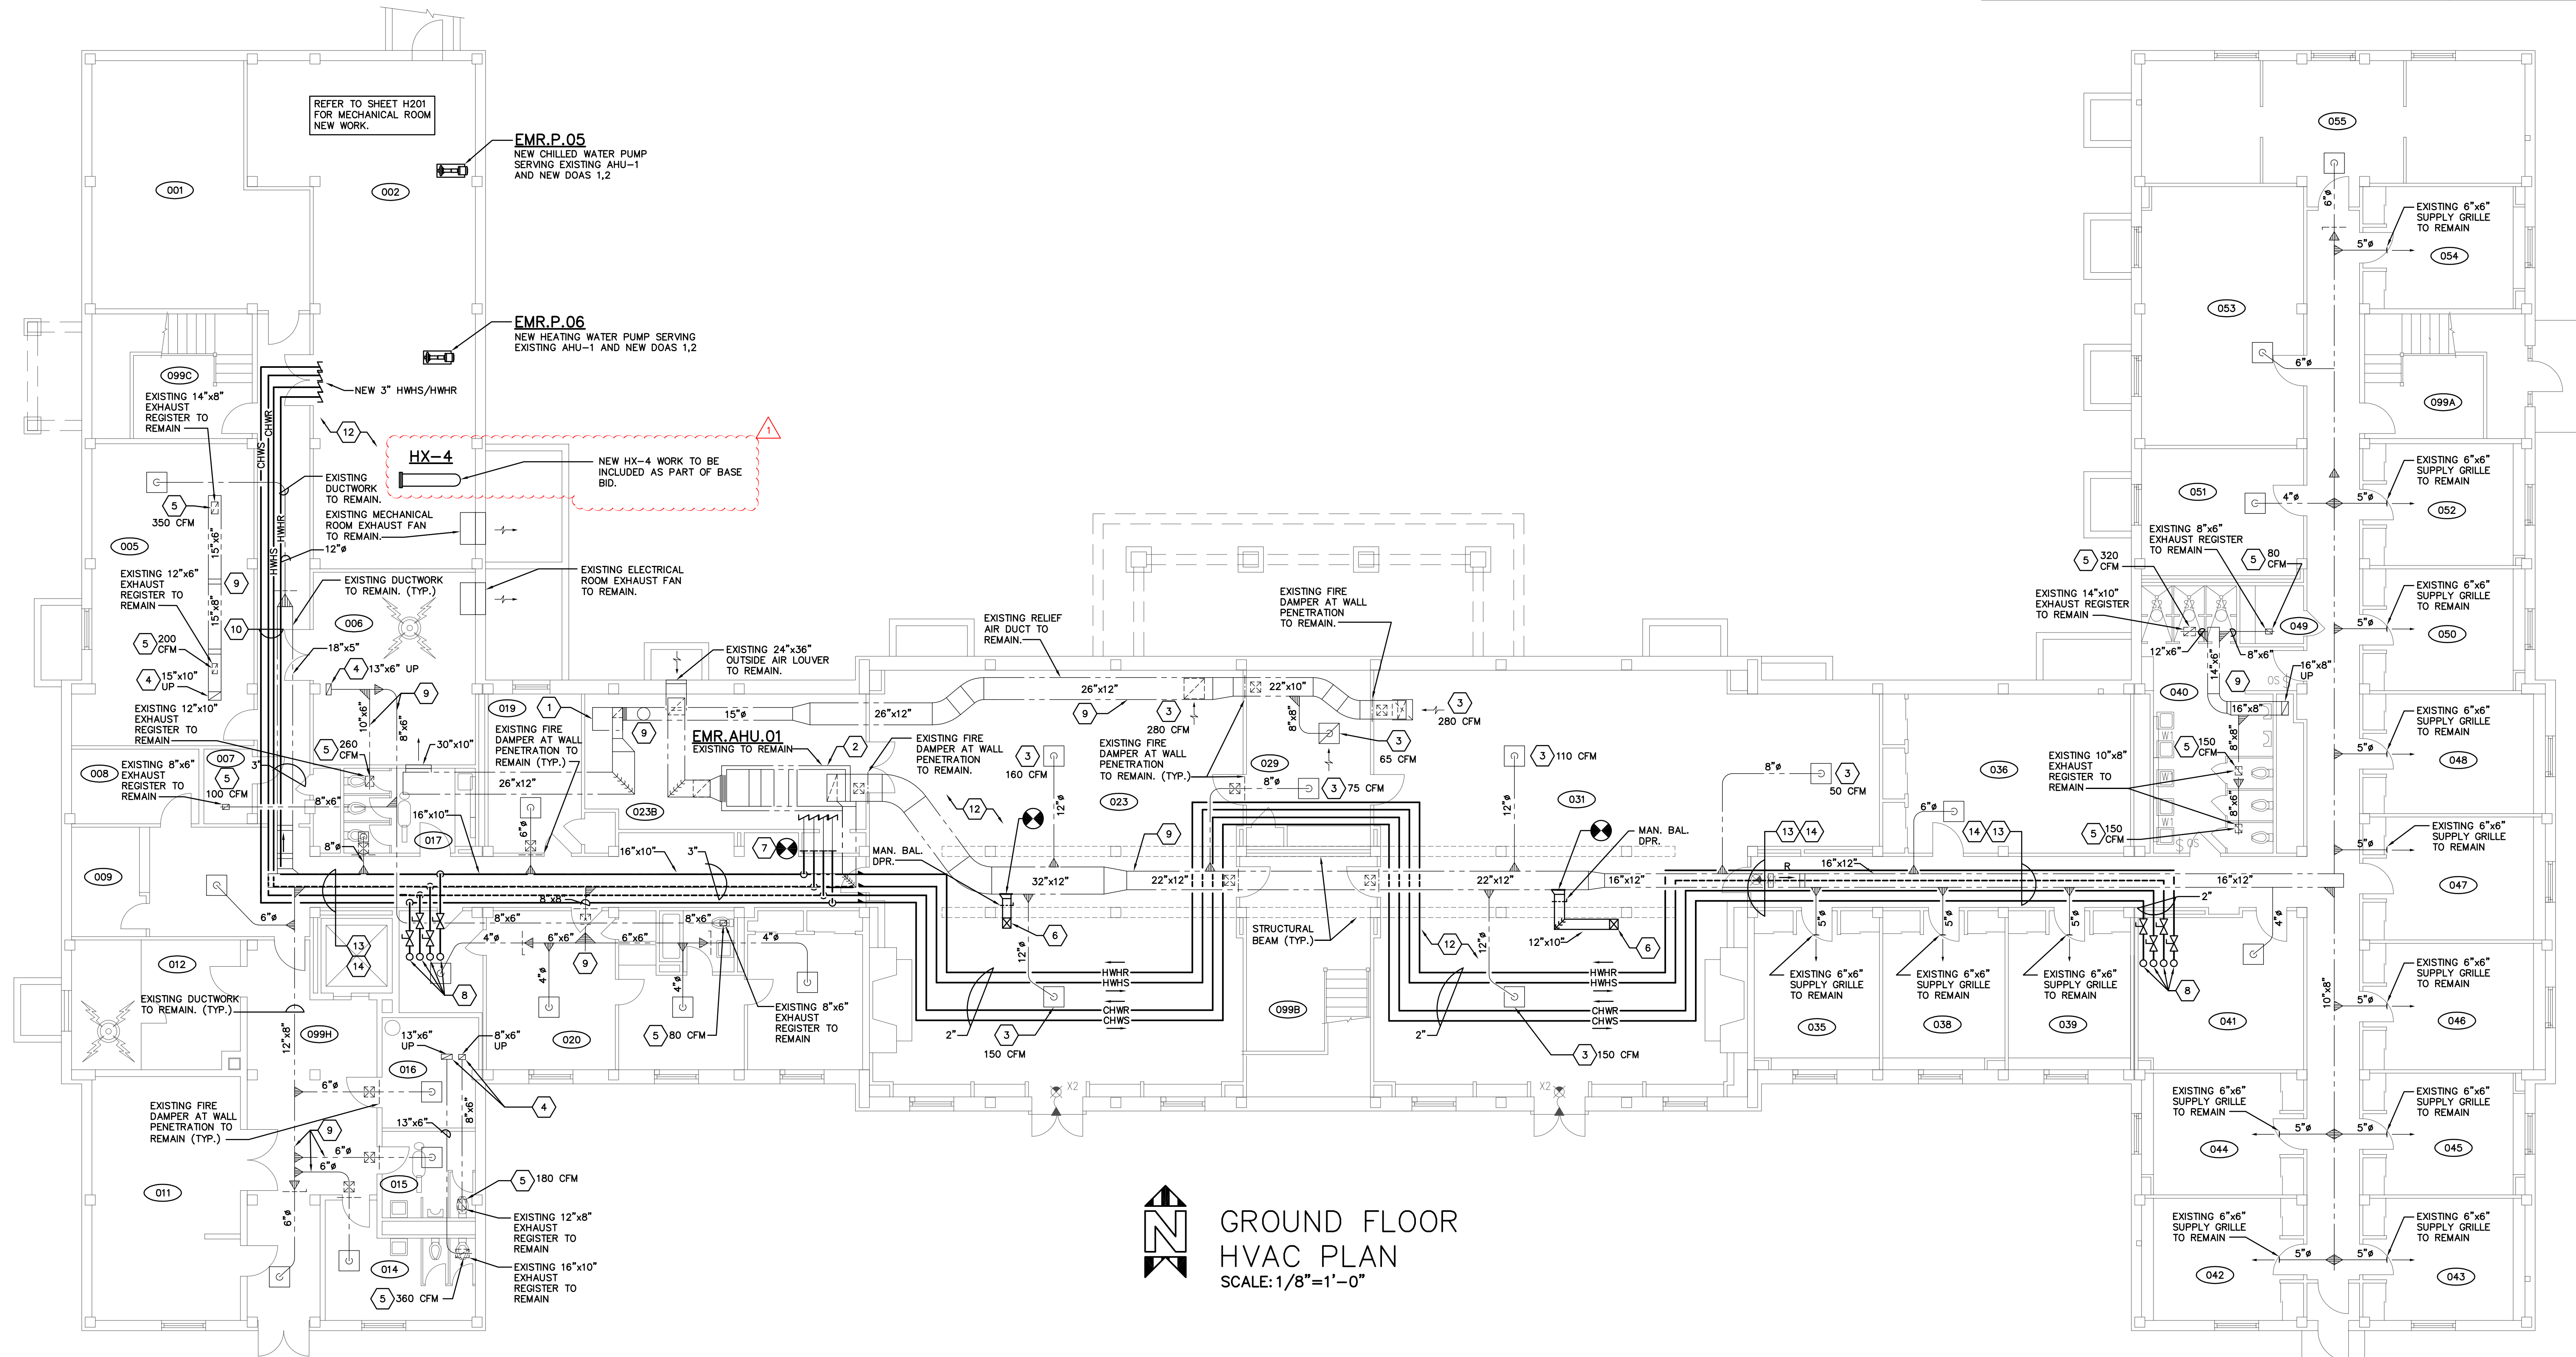

GROUND FLOOR
HVAC PLAN
SCALE: 1/8"=1'-0"

3-24-22	ADDENDUM 2
3-4-22	ISSUED FOR BID AND PERMIT
DATE	DESCRIPTION

H-100-21380.DWG
ASSOCIATE ENGINEER
PRATER
Engineering Associates, Inc.
6130 Wilcox Road
Dublin, Ohio 43016
(614) 766 4886
FAX: (614) 766 2354

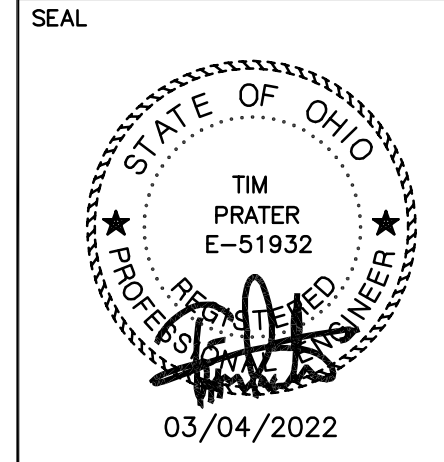

MIAMI UNIVERSITY
EMERSON HALL
VENTILATION IMPROVEMENTS

PREPARED FOR
MIAMI UNIVERSITY
PHYSICAL FACILITIES DEPARTMENT
OXFORD, OH

PREPARED BY
PRATER ENGINEERING ASSOCIATES
6130 WILCOX ROAD, DUBLIN, OHIO 43016

SCALE	DATE	DESIGNED BY	CHECKED BY	SHEET NO.
AS NOTED	03/04/2022	ARP	TP	H-100