



- CODED NOTES**
1. NEW OUTDOOR AIR LOUVER IN WALL AT WINDOW WELL. ENLARGE OPENING FOR NEW LOUVER DIMENSIONS. REFER TO SHT. H-100 FOR STRUCTURAL NOTES. INSTALL NEW BRICK LEDGE AT TOP OF NEW OPENING. REFER TO SHEET H-600 LOUVER SCHEDULE FOR SIZE.
 2. NEW COOLING COIL IN EXISTING AHU-2. REFER TO SHEET H-600 EQUIPMENT NOTE FOR CAPACITY DETAILS. PROVIDE ALL NECESSARY COIL SUPPORTS AND BLANK-OFF PANELS REQUIRED FOR INSTALLATION OF NEW COIL.
 3. NEW 28" DEEP O.A. PLENUM WITH ACCESS DOOR. 36"x28" INLET TO PLENUM. OUTLET TO MATCH EXIST. PRE-HEAT COIL FLANGE DIMENSION.
 4. PROVIDE NEW HX-4 AND ASSOCIATED PIPING UNDER ALTERNATE BID H-2. REFER TO EQUIPMENT NOTES ON SHEET H-600 AND SPECIFICATIONS.
 5. EXISTING PIPING TO REMAIN.
 6. EXISTING WATER SOFTENER EQUIPMENT TO REMAIN.
 7. EXISTING HEAT EXCHANGER HX-1 AND HX-2 TO REMAIN.
 8. EXISTING SUMP PUMP TO REMAIN.
 9. EXISTING DOMESTIC WATER HEATER STORAGE TANKS TO REMAIN.
 10. EXISTING PUMP TO REMAIN.

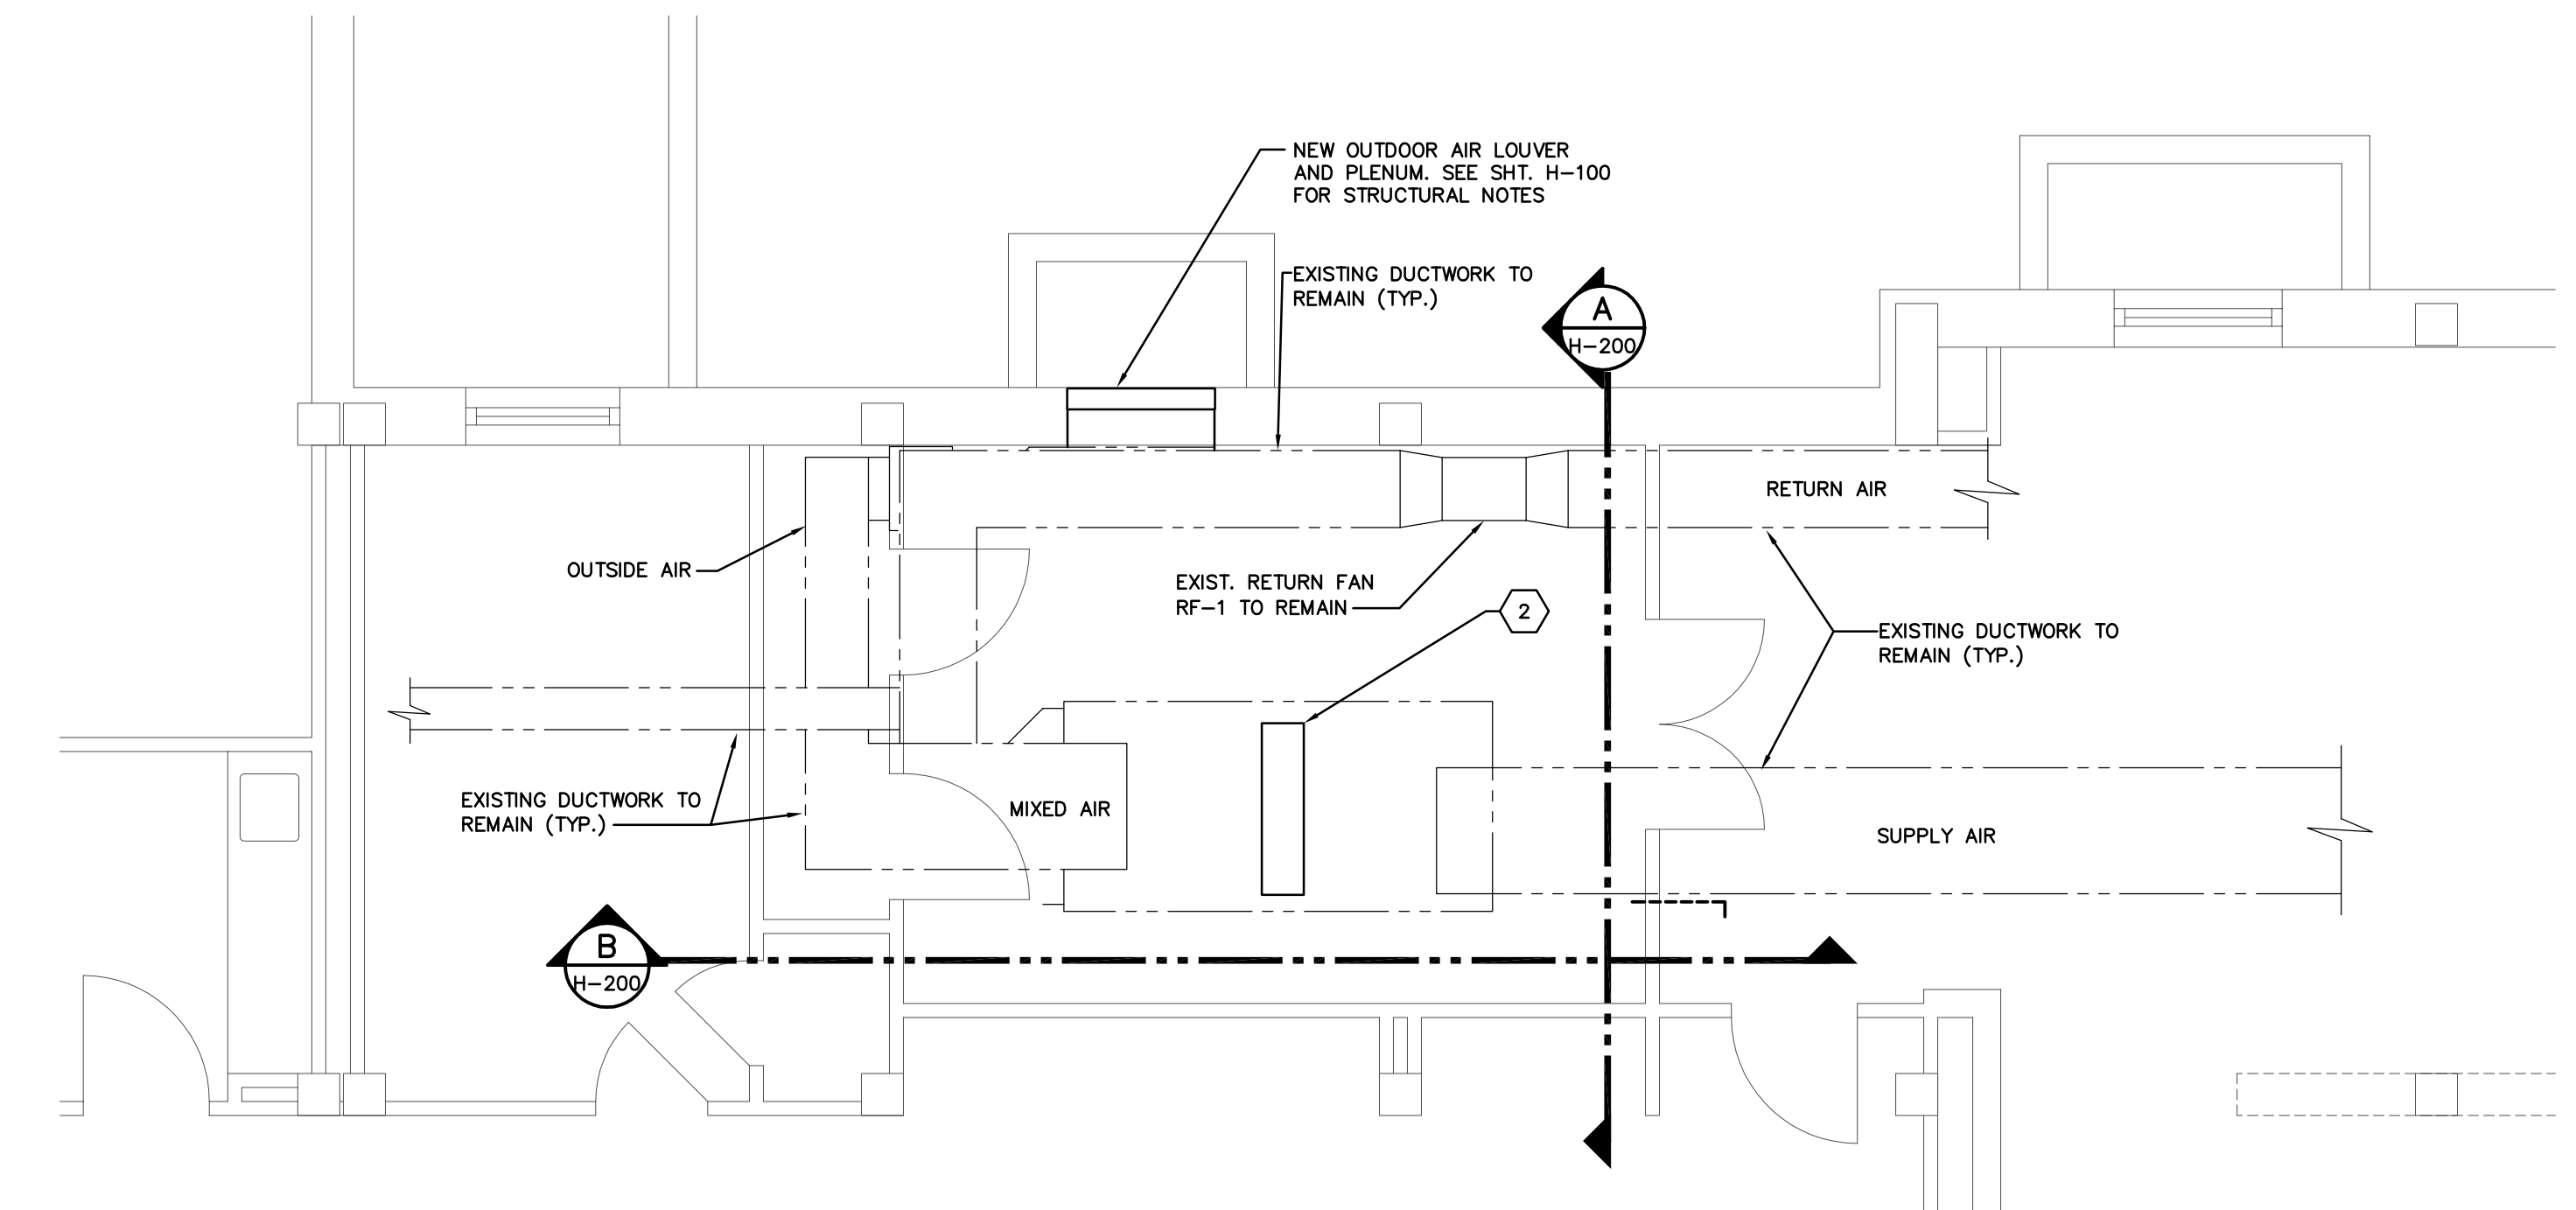

GROUND FLOOR MECH. RM. HVAC PLAN
 SCALE: 1/4" = 1'-0"

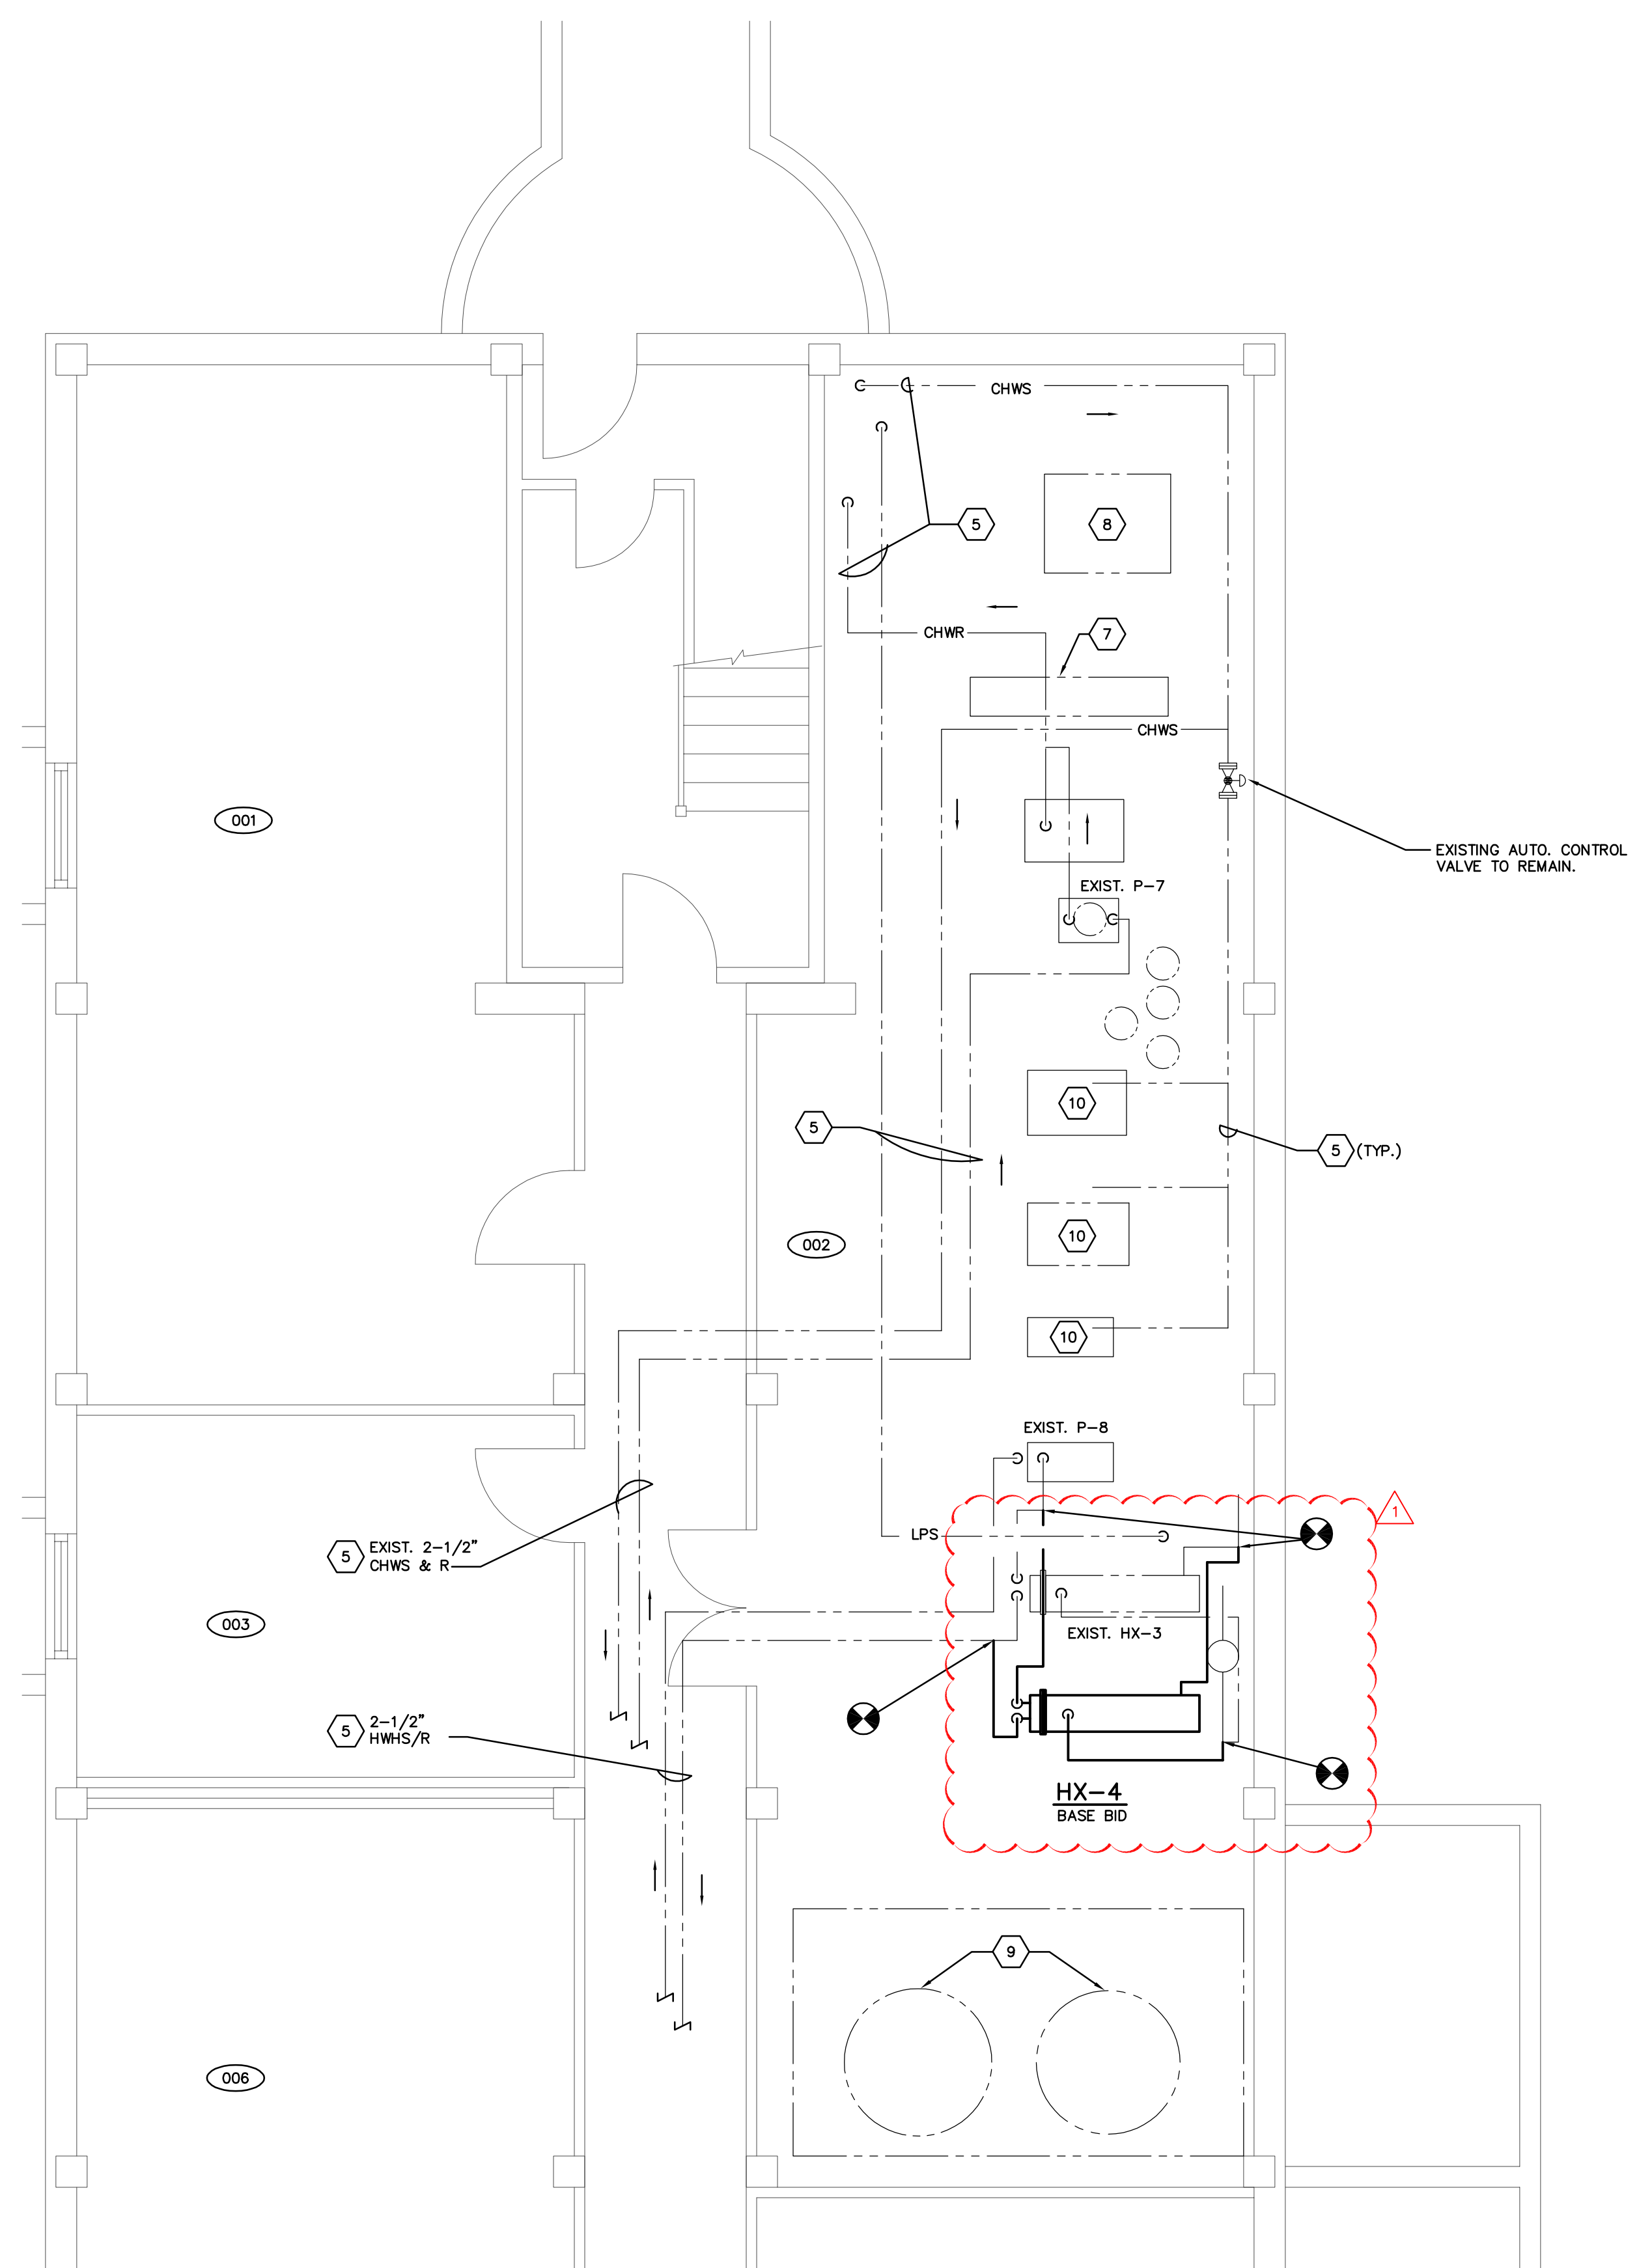

MECH. RM. 002 HVAC PLAN - ALTERNATE H-2
 SCALE: 1/4" = 1'-0"

DATE	DESCRIPTION
3-24-22	ADDENDUM 2
3-4-22	ISSUED FOR BID AND PERMIT

H-400-21379.DWG
 ASSOCIATE ENGINEER
PRATER Engineering Associates, Inc.
 6130 Wilcox Road
 Dublin, Ohio 43016
 (614) 766 4886
 FAX: (614) 766 2354

SEAL
 STATE OF OHIO
 TIM PRATER
 E-51932
 03/04/2022

MIAMI UNIVERSITY
 MORRIS HALL
 VENTILATION IMPROVEMENTS

PREPARED FOR
 MIAMI UNIVERSITY
 PHYSICAL FACILITIES DEPARTMENT
 OXFORD, OH

PREPARED BY
 PRATER ENGINEERING ASSOCIATES
 6130 WILCOX ROAD; DUBLIN, OHIO 43016

SHEET TITLE
 ENLARGED HVAC PLANS

SHEET NO.
H-200

SCALE AS NOTED
 DATE 3/4/2022
 DESIGNED BY B. OGLE
 CHECKED BY T. PRATER

